 

 


PLAN @ MEZZANINE LEVEL

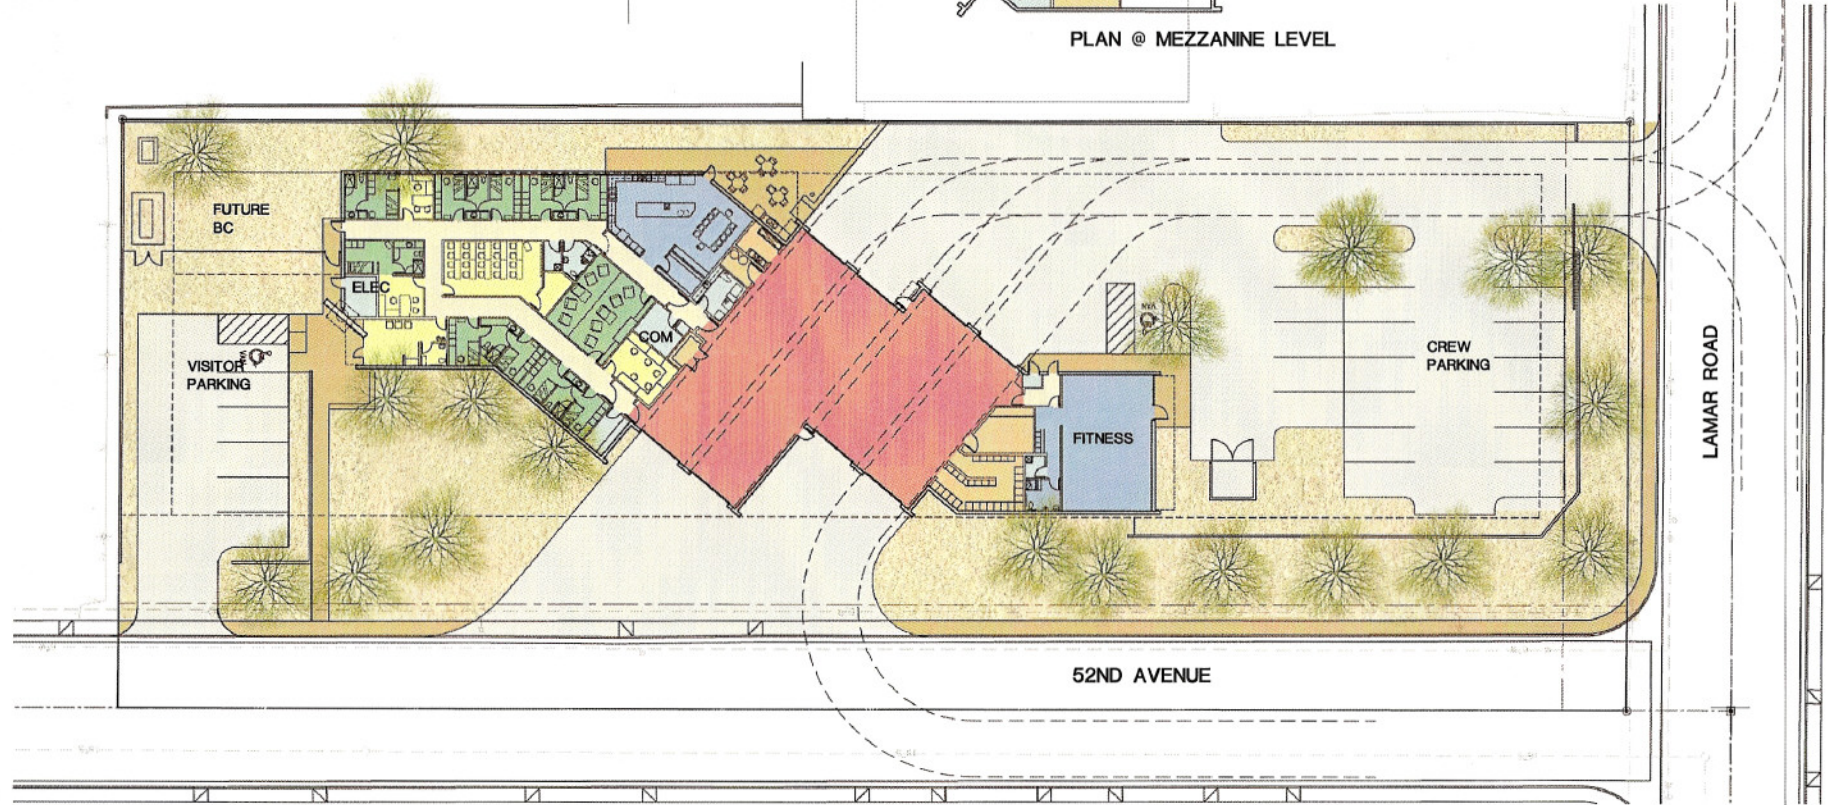

SCHEMATIC SITE PLAN

SCALE : 1/16" = 1'-0"



RELOCATION OF FIRE STATION 151

SCHEMATIC DESIGN 04.19.07



DWL ARCHITECTS